


# LEGEND

- F FIRE EXTINGUISHER
- H FIRE HYDRANT
- + FIRST AID
- E EMERGENCY ASSEMBLY POINT
- WHARF ALARM (PORTABLE)
- A SITE EAS (EMERGENCY ALARM SYSTEM)
- T EMERGENCY RESPONSE TRAILER
- AED DEFIBRILLATOR

IN THE EVENT OF AN EMERGENCY, RING PORT SERVICES ON 09 432 5018 TO OBTAIN PARAMEDICS, FIRE FIGHTING, DEFIBRILLATOR, RESPONSE TRAILER OR OTHER ASSISTANCE

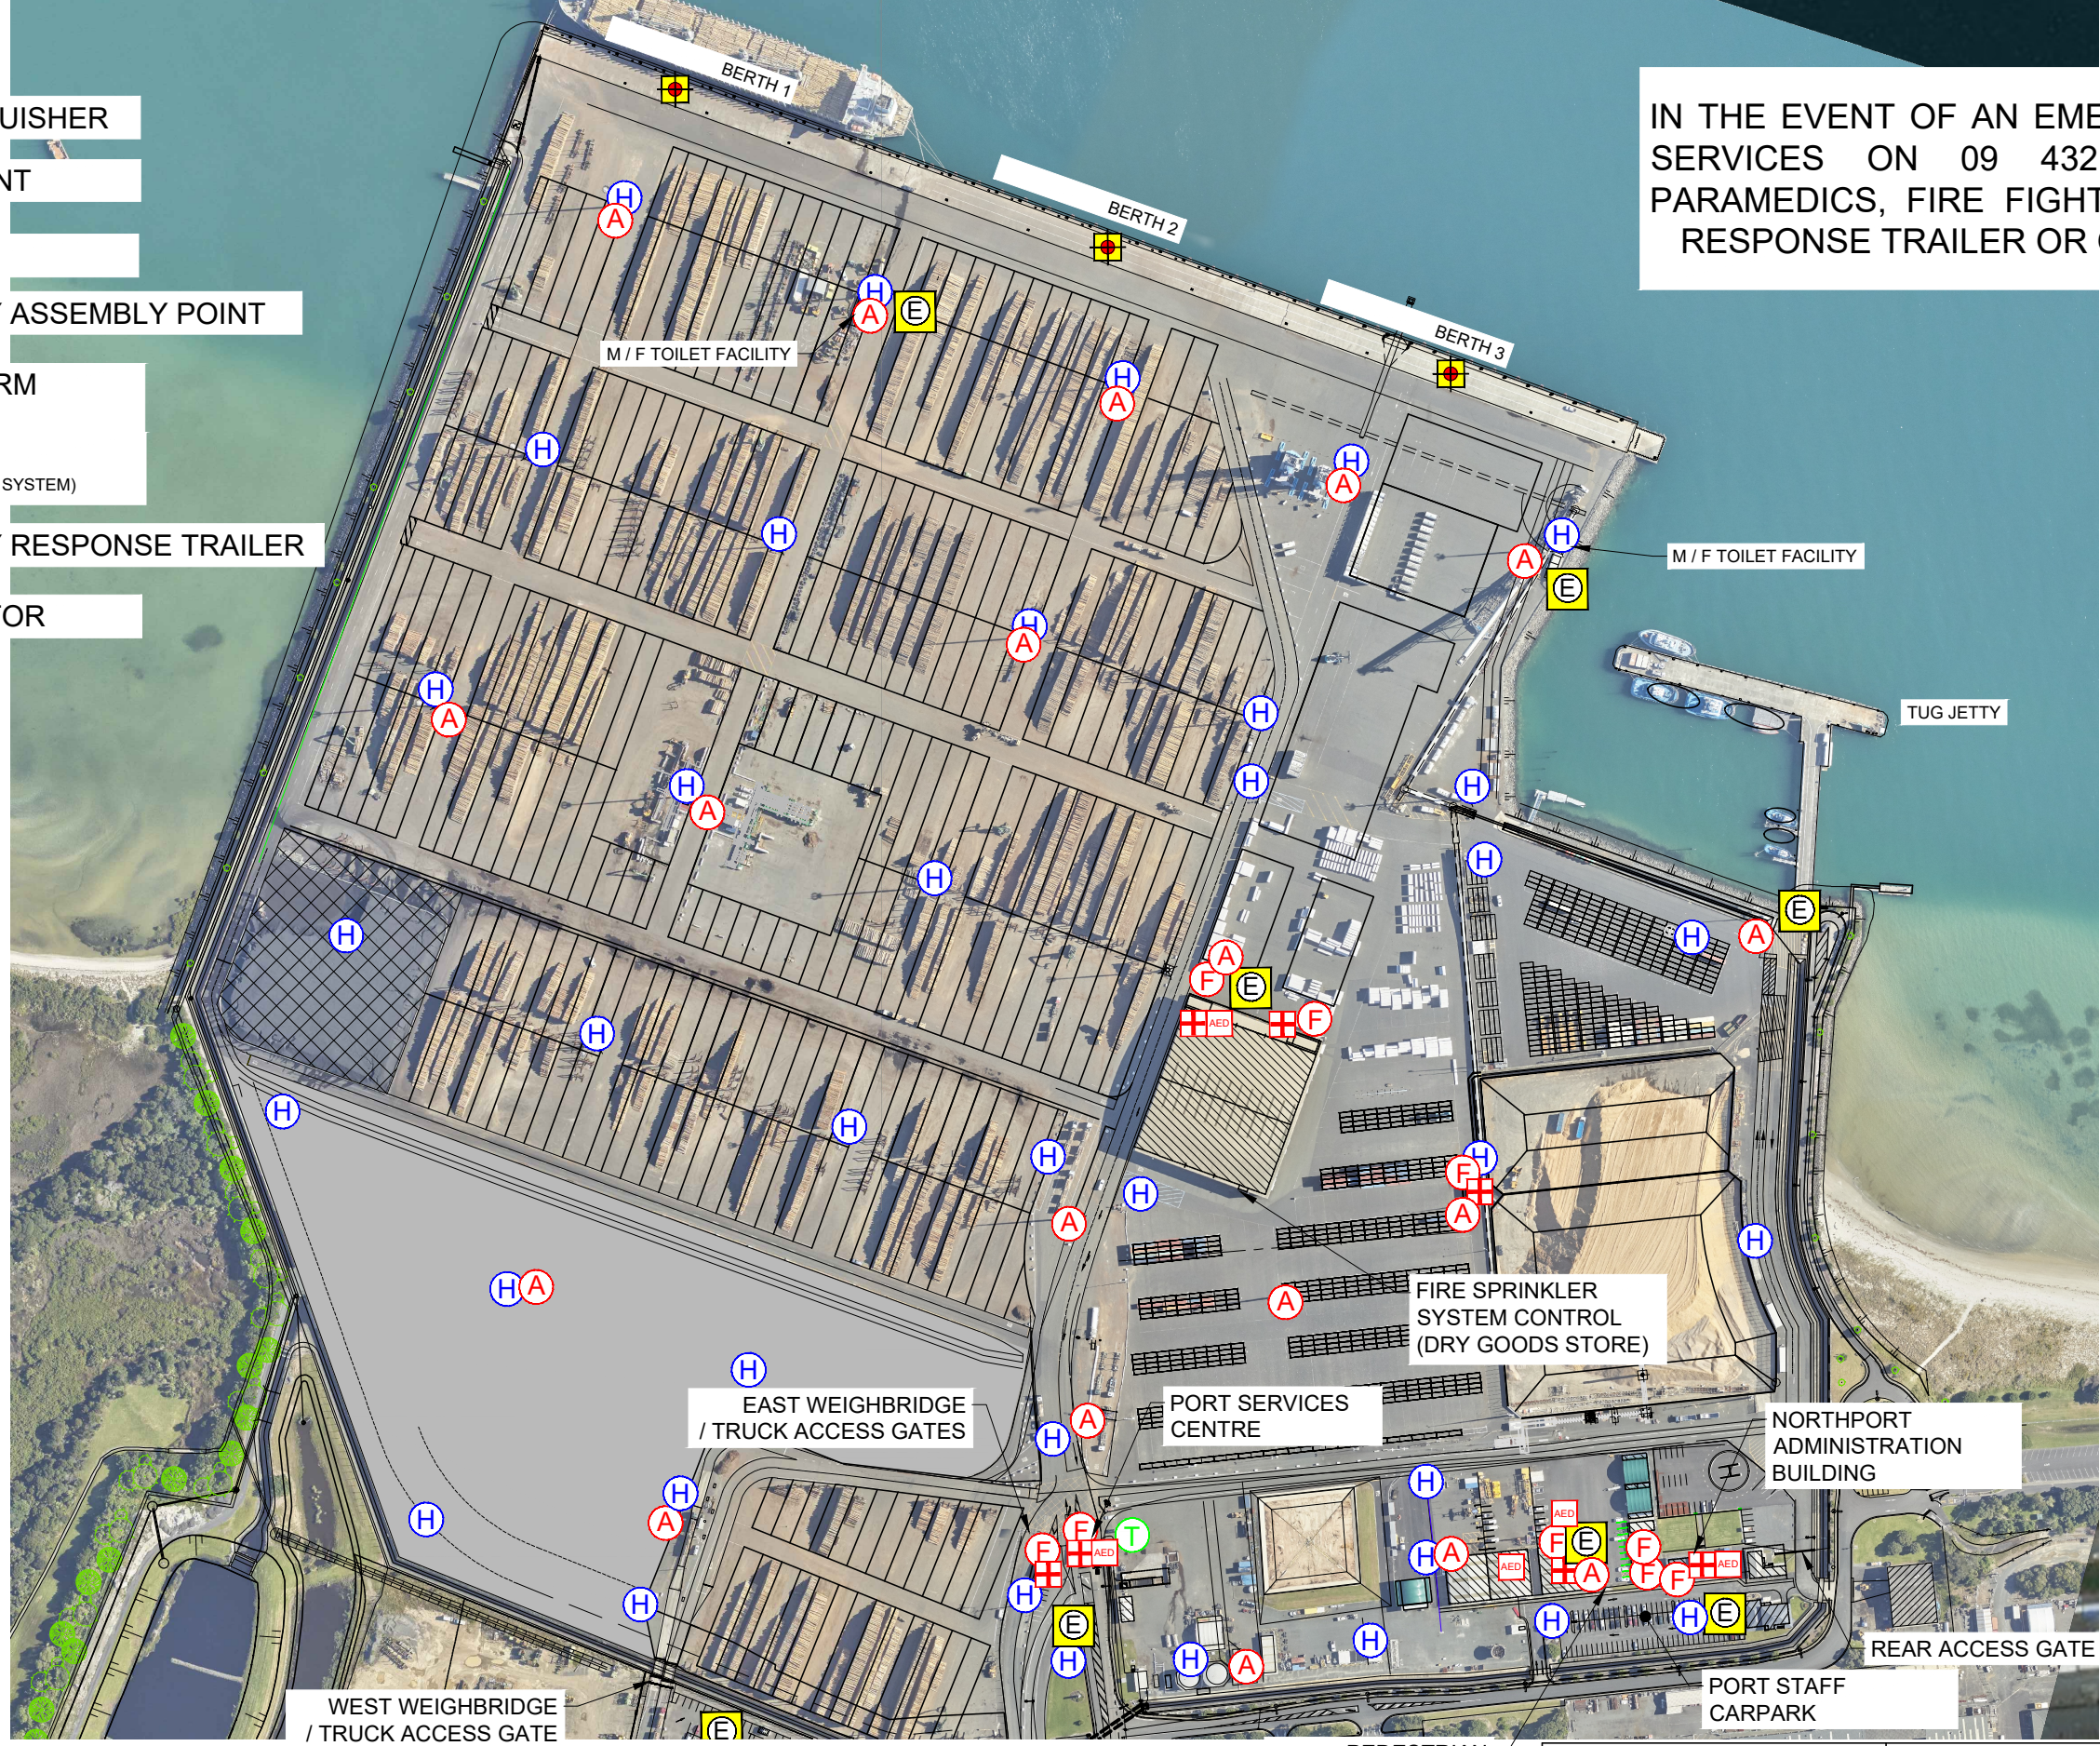

ISSUE	DATE	DETAILS	APPRVD	BY

**Northport**  
 P.O BOX 44  
 RUAKAKA, NEW ZEALAND  
 TEL 09 432 5010

Title:		NORTHPORT FACILITY EMERGENCY SITE PLAN		
Path k:\engineer\northp_dwg\d60-00-099r6 proposed alarm upgrades.dwg	Dwg No D60-00-099	Scale NTS	Date FEB 2025	Issue R6
Drawn: B SWEENY	Checked:	Scale: NTS	Date: FEB 2025	Sheet: 01